


EMERSON ST

WIEHE AVE

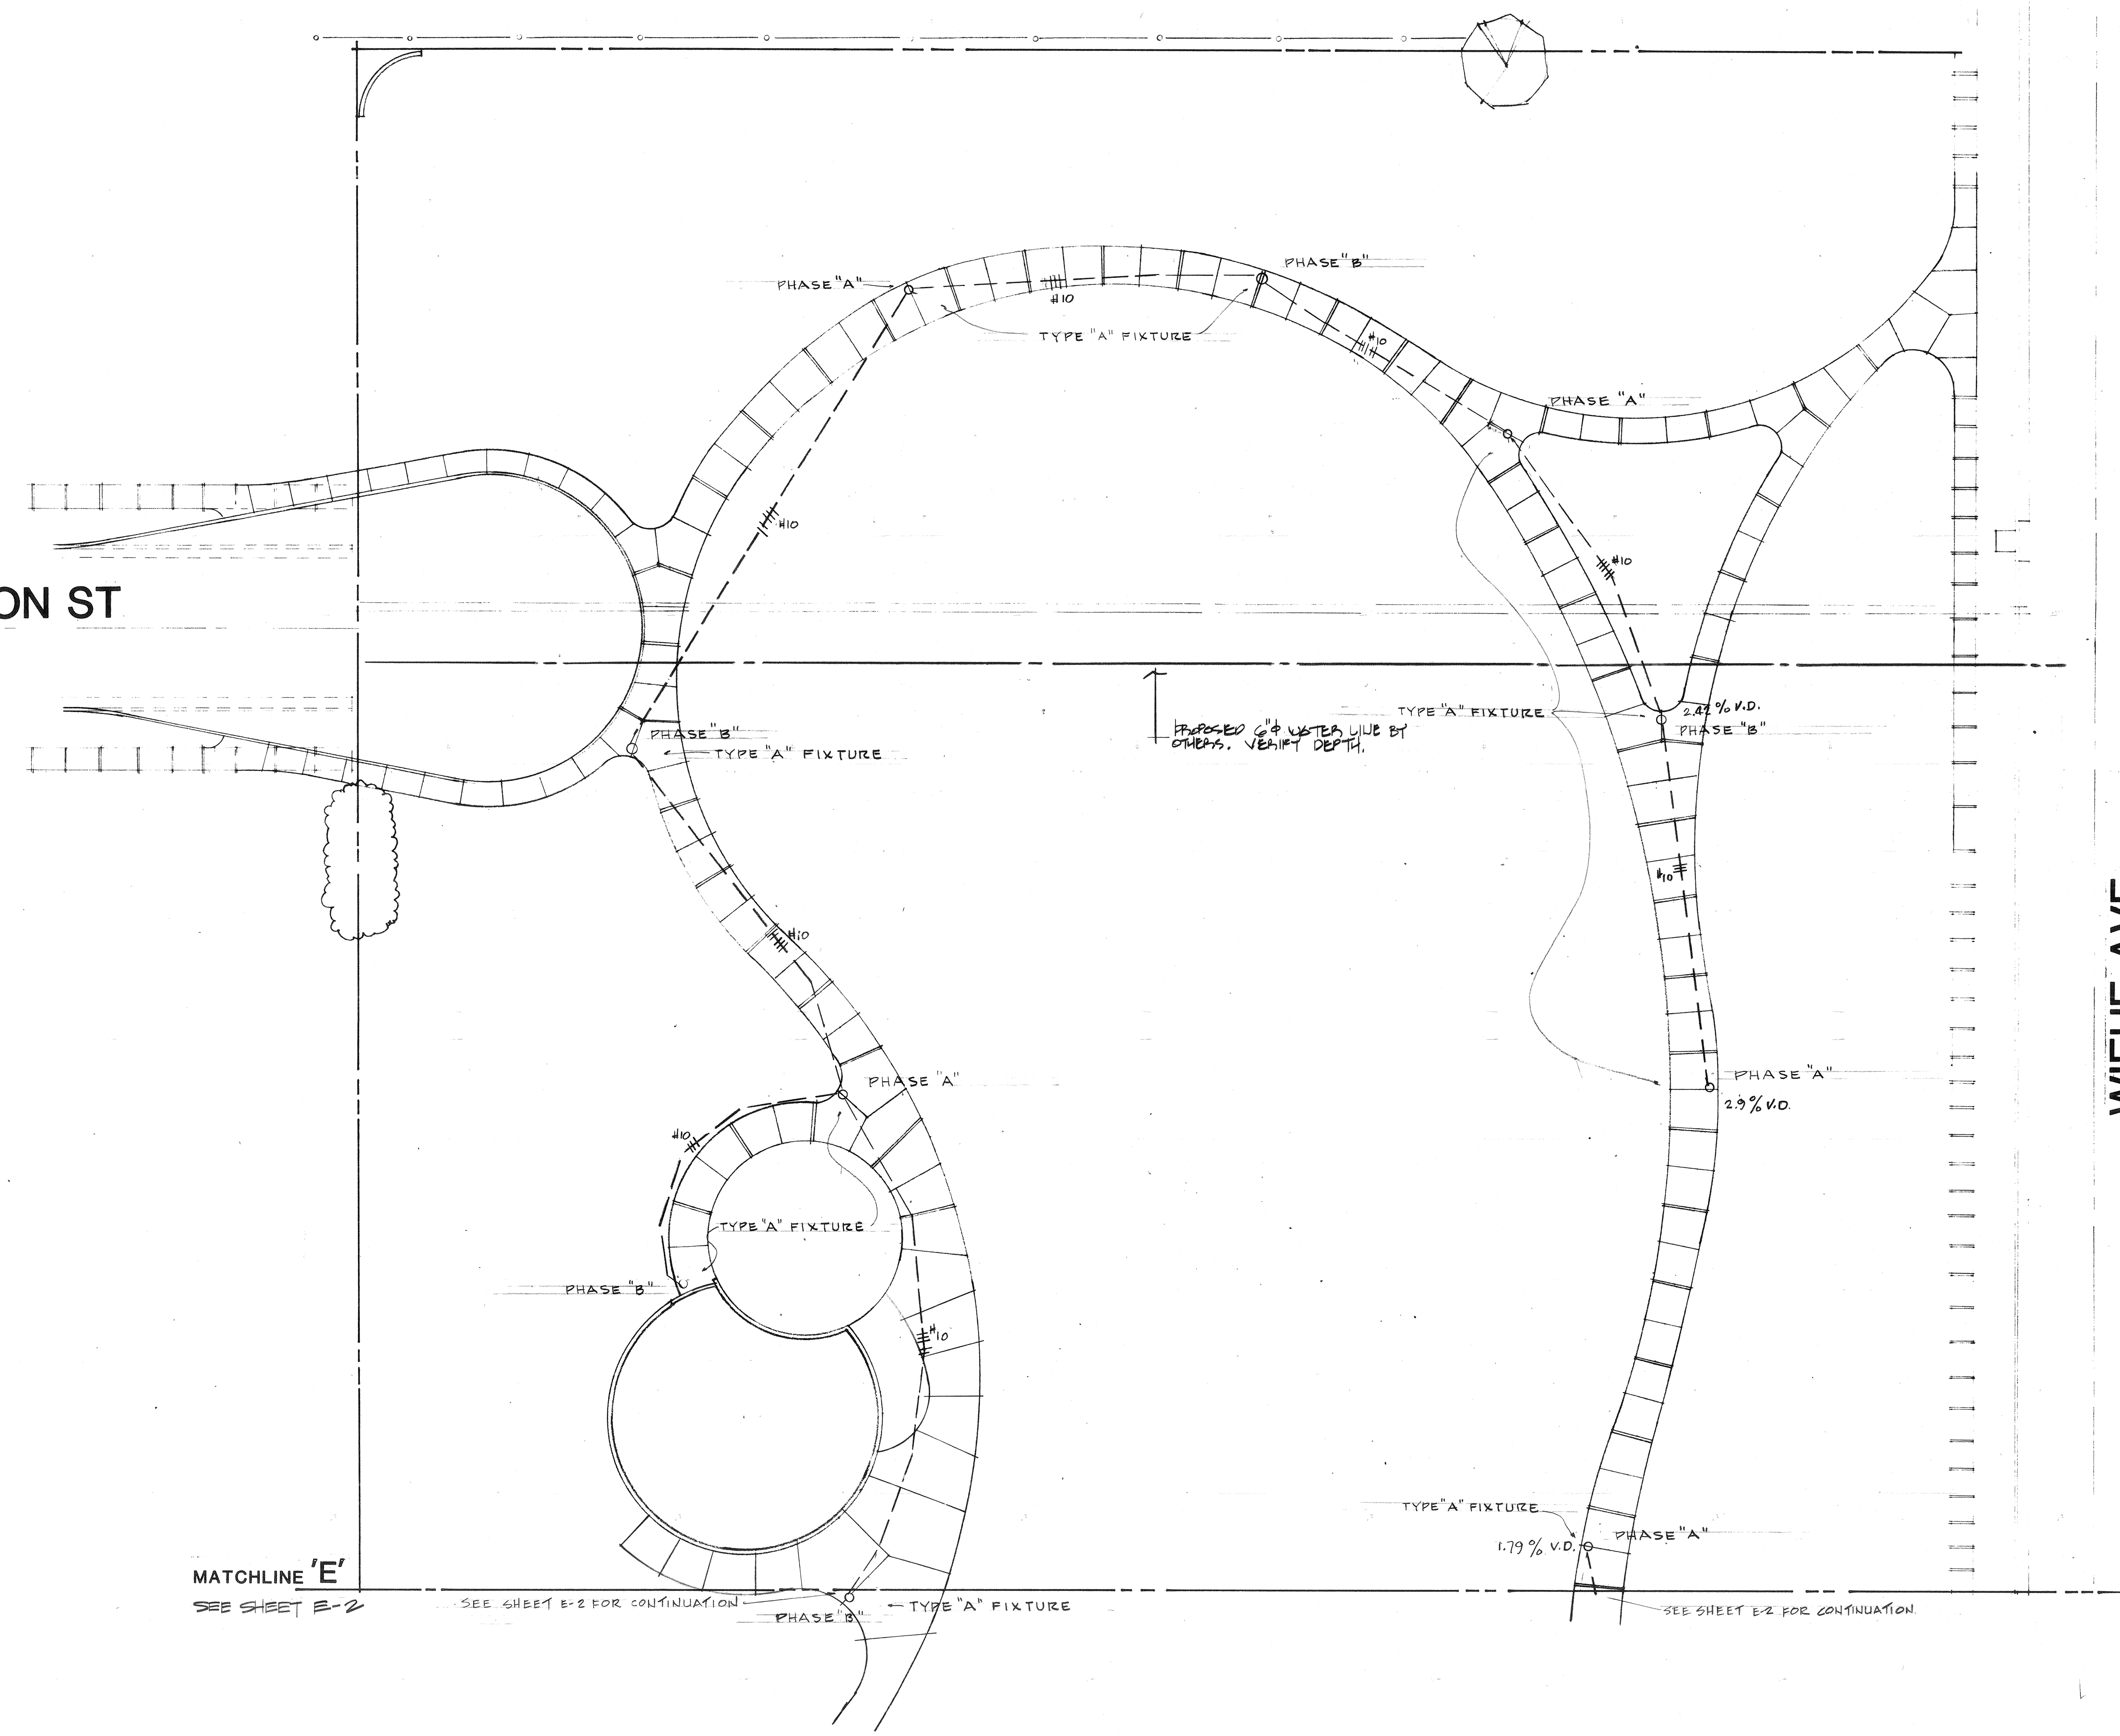

elliott/
maloney
landscape architecture
planning

3903 Brockton Avenue, Suite 2, Riverside, California 92501 (714) 369-0700

SHEET DESCRIPTION:
LIGHTING PLAN


PROJECT:
**MOUNTAIN VIEW
PARK**

REVISIONS	DATE: 22 MAY 86
JOB: 85047M	
DRAWN BY: JT	
CHECKED BY:	

SCALE: 1" = 20'-0"

SHEET:
E-1
OF 28

NORTH

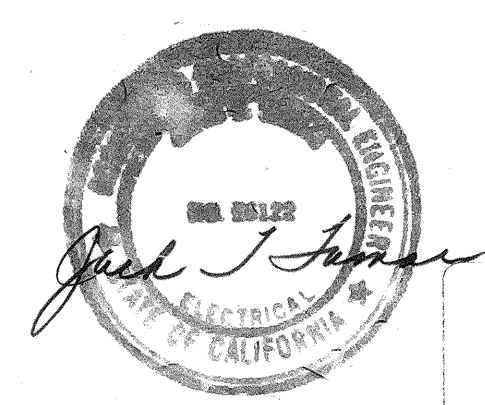

KEN MATSUOKA E.E. INC.
479 N. Tustin Ave.
ORANGE, CALIFORNIA
(714) 638-7761 CA. Reg. #E-2617

